



REVISIONS



Leventis & Leventis Architects
 16, Emmanouil Roïdis street,
 Limassol, Cyprus
 P.C 3031
 T: +357 25 362 846
 F: +357 25 373 288
 info@leventisgroup.com
 http://www.leventisgroup.com

ΕΡΓΟ/PROJECT

CITY MEDICAL CENTER

Υπογραφή Αρχιτέκτονα/Architect's Signature

Υπογραφή/Signatures

Checked by G.L.

Στάδιο Μακέτας/Drawing Status
 MARKETING PLANS

Σχέδιο/Drawing
 BASEMENT FLOOR PLAN

Ημερομηνία Κατάθεσης/Submission Date
 ΠΟΛΕΟΔΟΜΙΚΗ ΑΔΕΙΑ 13/03/2023

ΚΑΙΜΑΚΑ/ SCALE	1:100	ΑΡ. ΣΧΕΔΙΟΥ/ DRAWING No.	
ΗΜΕΡΟΜΗΝΙΑ/ DATE	8/5/2024		- M -
ΑΡ. ΜΕΛΕΤΗΣ/ PROJECT No.	2020-110		001

© 2023 Leventis & Leventis Architects
 All Rights Reserved.
 All materials embodied herein constitute an original work by the Architect.
 The Architect owns all copyrights herein. The viewer may not reproduce, display or distribute this work or prepare derivative work based on this work without the express written consent of the copyright owner.



NOTES / ΠΑΡΑΤΗΡΗΣΕΙΣ

REVISIONS



Leventis & Leventis Architects
 16, Emmanouil Roïdis street,
 Limassol, Cyprus
 P.C 3031
 T: +357 25 362 846
 F: +357 25 373 288
 info@leventisgroup.com
 http://www.leventisgroup.com

ΕΡΓΟ/PROJECT
 CITY MEDICAL CENTER

Υπογραφή Αρχιτέκτονα/Architect's Signature

ΕΤΕΚ Α / 69223

Υπογραφή/Signatures

Checked by G.L.


Στάδιο Μελέτης/Drawing Status
 MARKETING PLANS

Σχέδιο/Drawing
 GROUND FLOOR PLAN


Ημερομηνία Κατάθεσης/Submission Date
 ΠΟΛΙΤΕΥΜΑΤΙΚΗ ΑΔΕΙΑ 13/03/2023

ΚΑΙΜΑΚΑ/ SCALE	1:100	ΑΡ. ΣΧΕΔΙΟΥ/ DRAWING No.	- M - 002
ΗΜΕΡΟΜΗΝΙΑ/ DATE	8/5/2024		
ΑΡ. ΜΕΛΕΤΗΣ/ PROJECT No.	2020-110		

© 2023 Leventis & Leventis Architects
 All Rights Reserved.
 All materials embodied herein constitute an original work by the Architect.
 The Architect owns all copyrights herein. The viewer may not reproduce, display or distribute this work or prepare derivative work based on this work without the express written consent of the copyright owner.

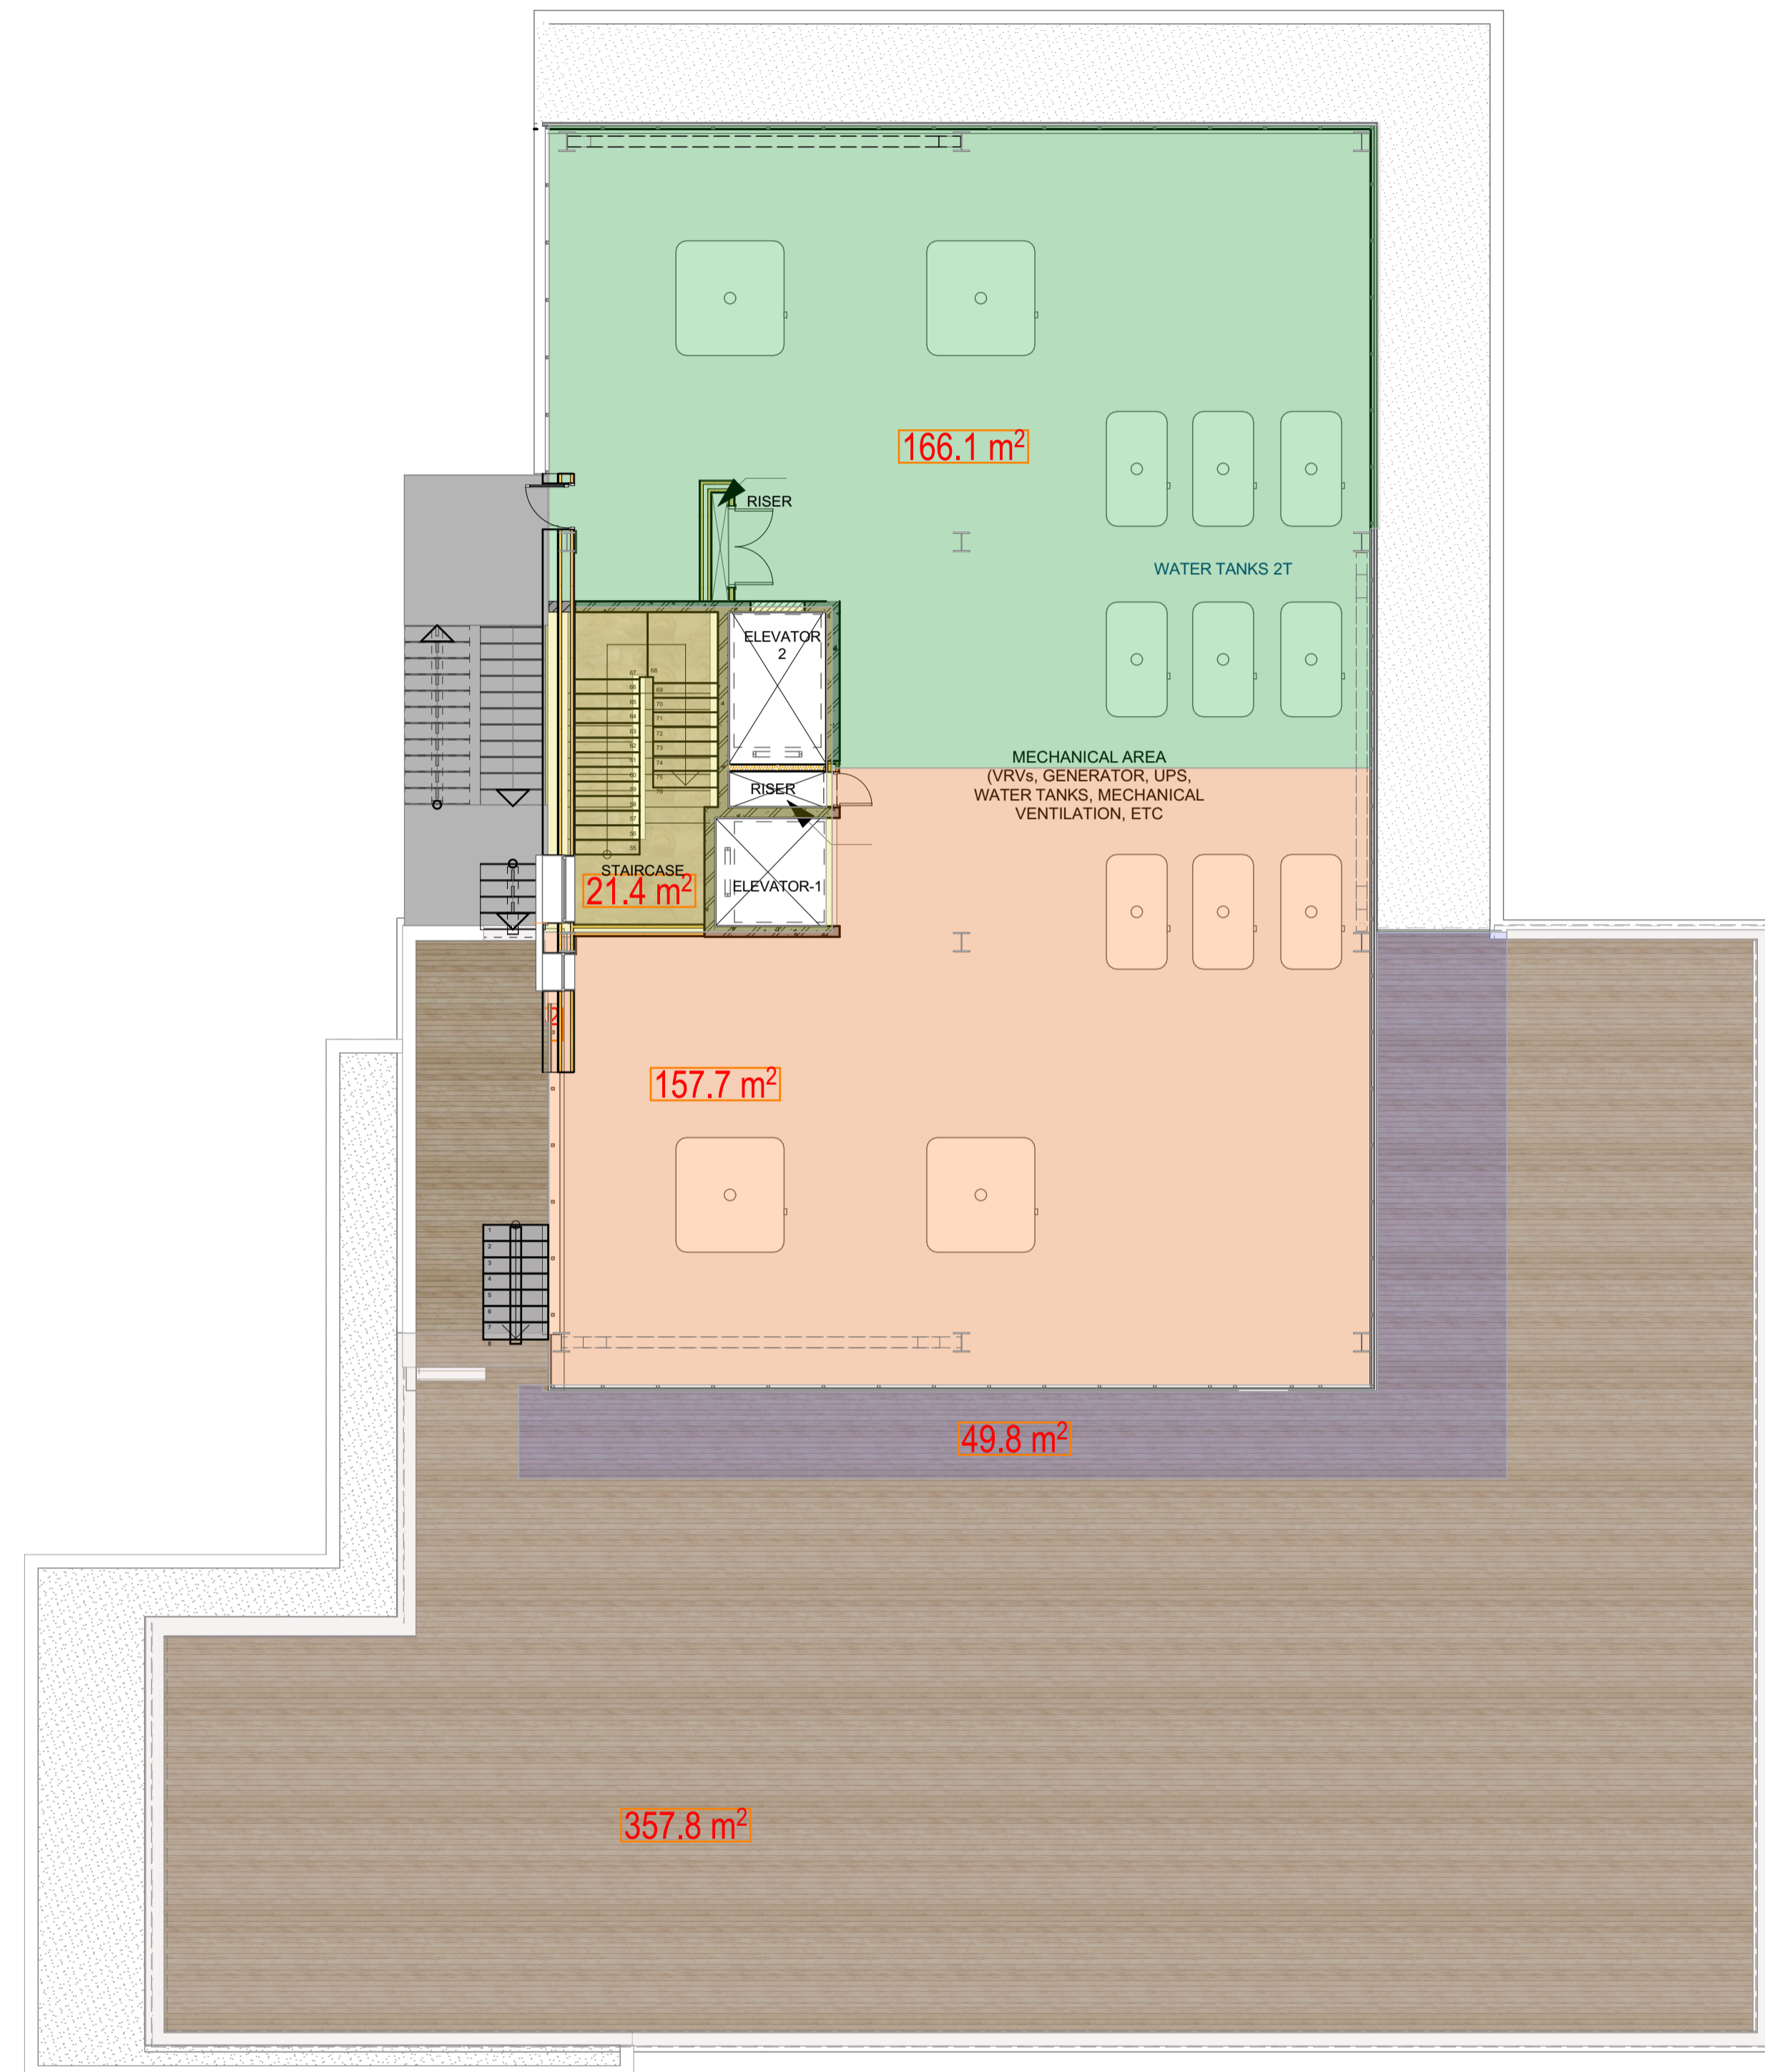

1. MEZZANINE/MECHANICAL FLOOR PLAN
1:100

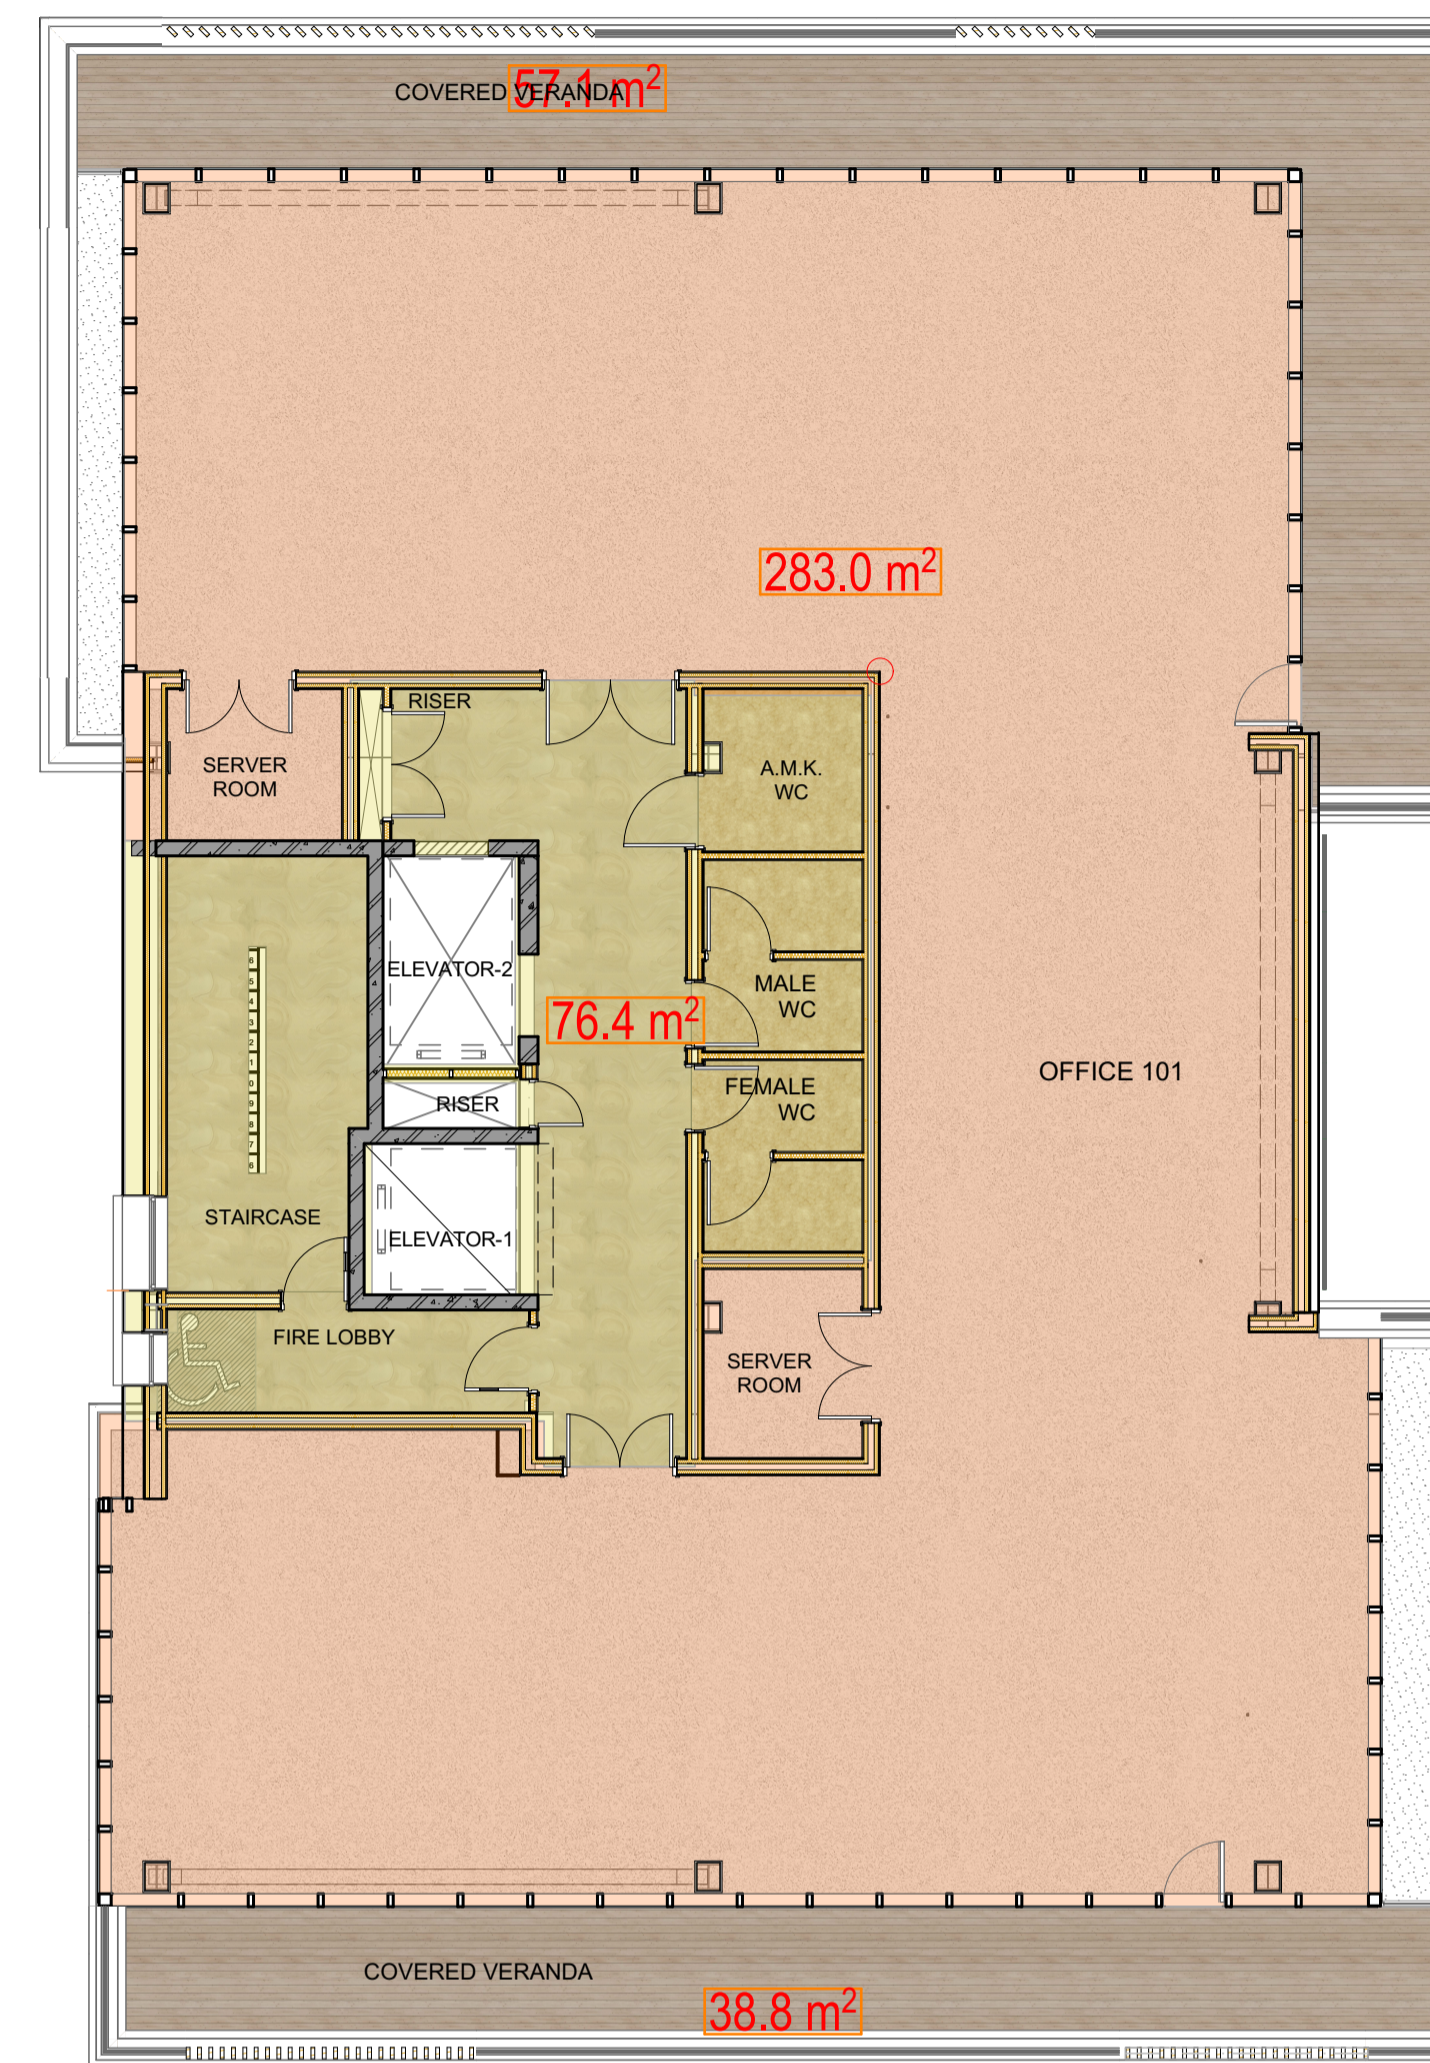

2. 1 ST FLOOR PLAN
1:100

NOTES / ΠΑΡΑΤΗΡΗΣΕΙΣ

REVISIONS



Leventis & Leventis Architects
16, Emmanouil Roïdis street,
Limassol, Cyprus
P.C 3031
T: +357 25 362 846
F: +357 25 373 288
info@leventisgroup.com
http://www.leventisgroup.com

ΕΡΓΟ/PROJECT

CITY MEDICAL CENTER

Υπογραφή Αρχιτέκτονα/Architect's Signature

ΕΤΕΚ Α / 69223

Υπογραφή/Signatures

Checked by G.L.


Στάδιο Μελέτης/Drawing Status
MARKETING PLANS

Σχέδιο/Drawing
MEZZANINE & 1ST FLOOR PLAN


Ημερομηνία Κατάθεσης/Submission Date
ΠΟΛΥΤΕΧΝΙΚΗ ΑΔΕΙΑ 13/03/2023

ΚΛΙΜΑΚΑ/ SCALE	1:100	ΑΡ. ΣΧΕΔΙΟΥ/ DRAWING No.
ΗΜΕΡΟΜΗΝΙΑ/ DATE	8/5/2024	- M -
ΑΡ. ΜΕΛΕΤΗΣ/ PROJECT No.	2020-110	003

© 2023 Leventis & Leventis Architects
© All Rights Reserved.
All materials embodied herein constitute an original work by the Architect.
The Architect owns all copyrights herein. The viewer may not reproduce, display or distribute this work or prepare derivative work based on this work without the express written consent of the copyright owner.

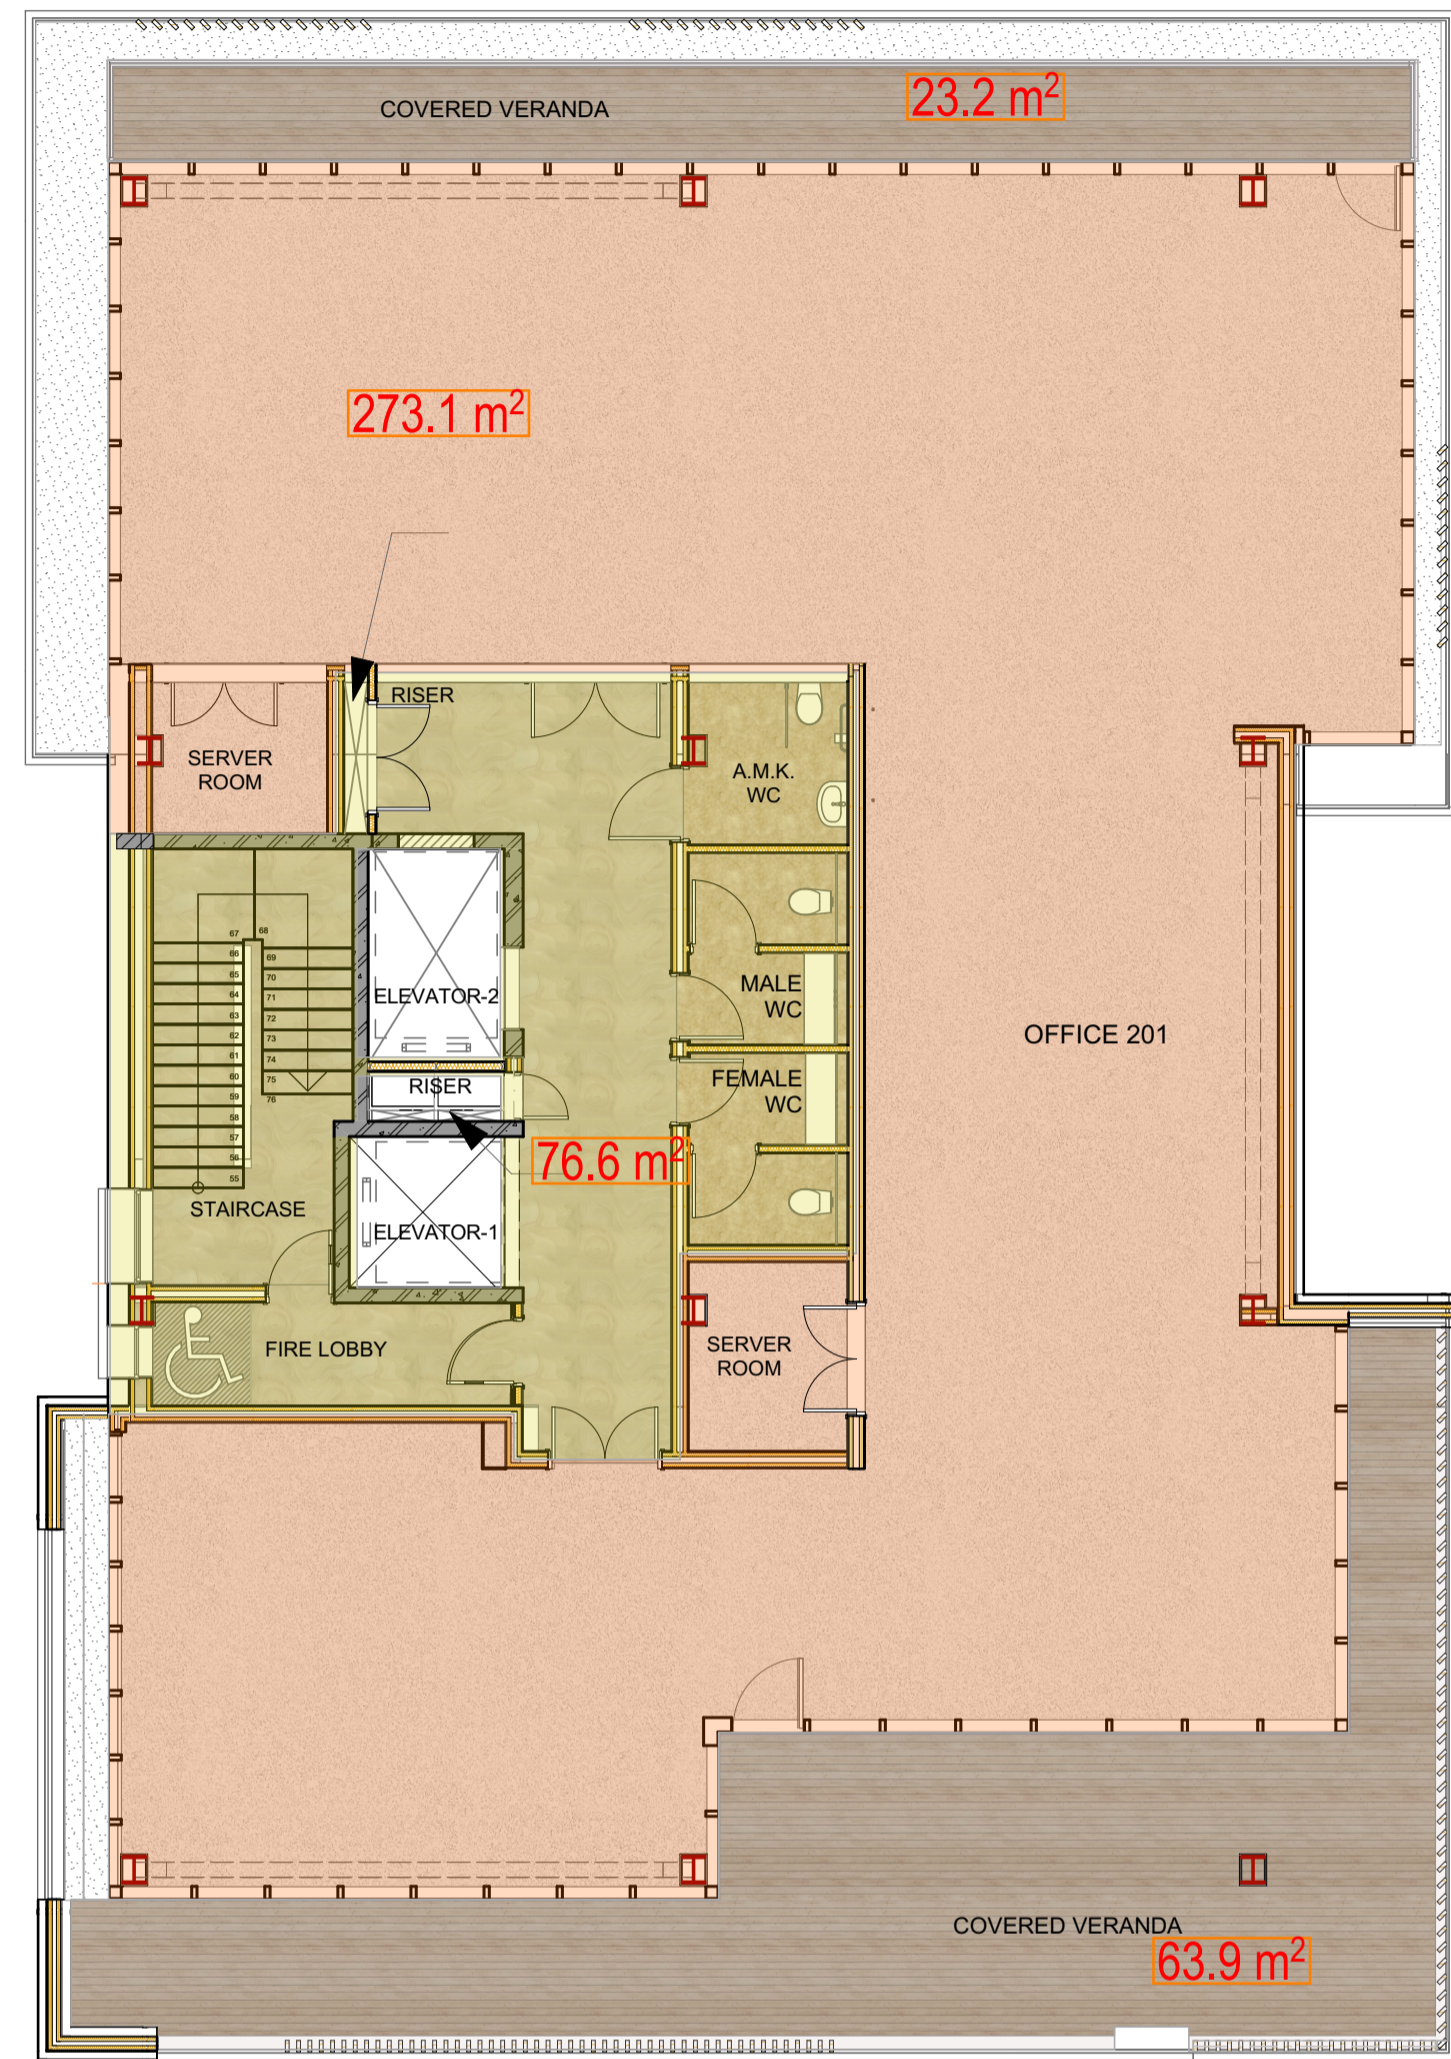

3. | 2ND FLOOR PLAN
1:100

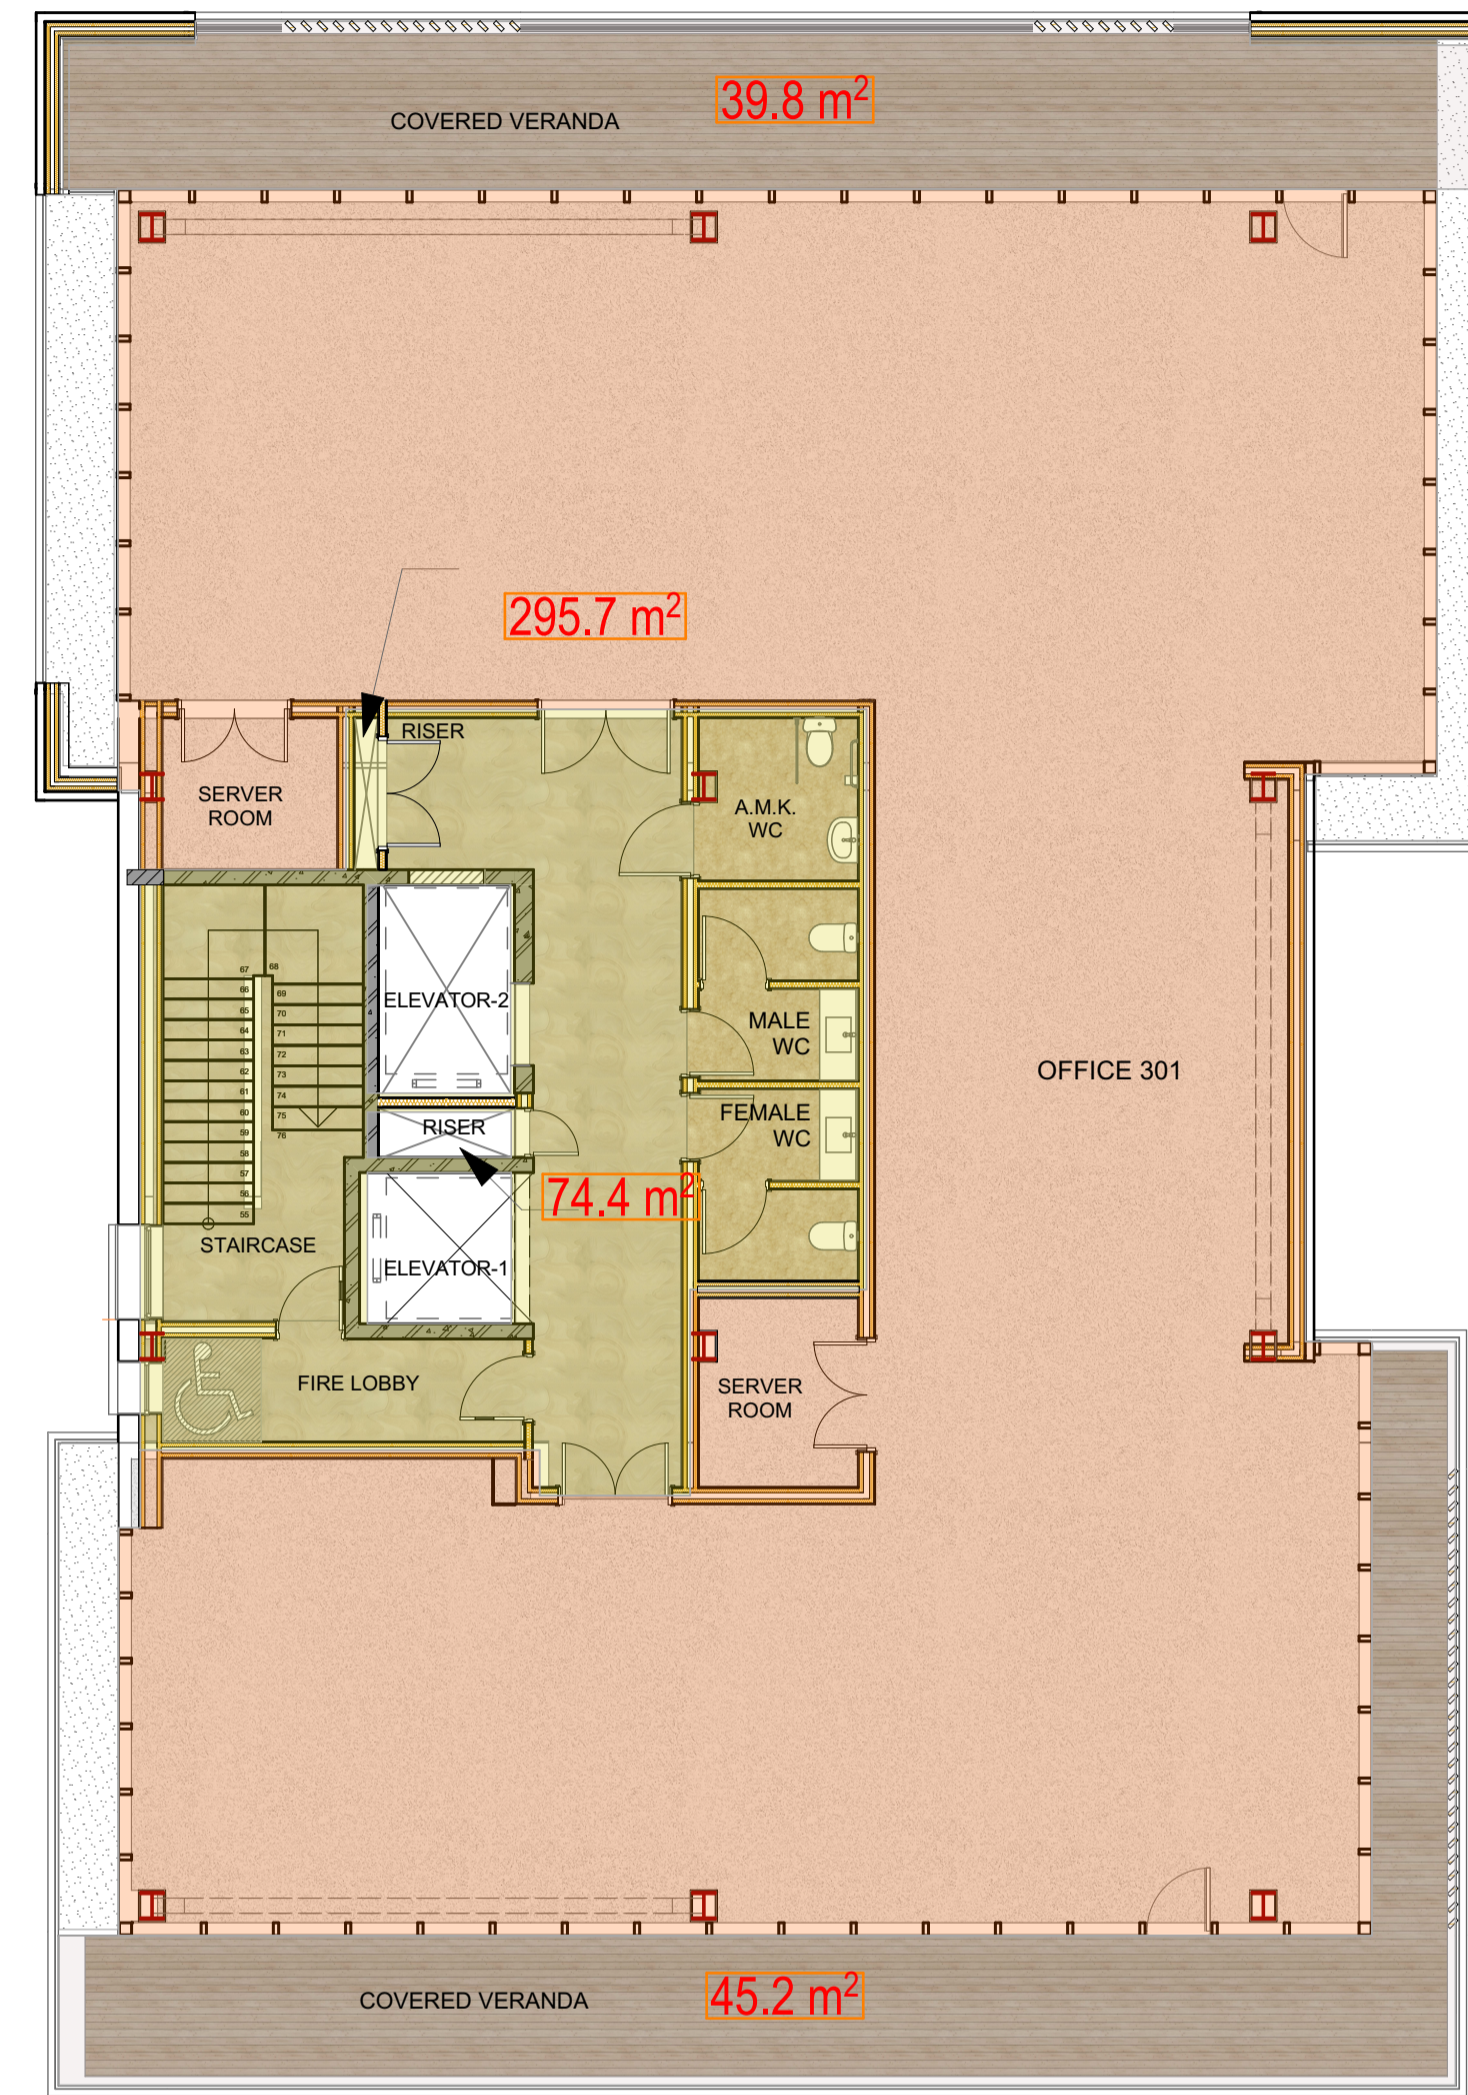

4. | 3RD FLOOR PLAN
1:100

NOTES / ΠΑΡΑΤΗΡΗΣΕΙΣ

REVISIONS



Leventis & Leventis Architects
16, Emmanouil Roïdis street,
Limassol, Cyprus
P.C 3031
T: +357 25 362 846
F: +357 25 373 288
info@leventisgroup.com
http://www.leventisgroup.com

ΕΡΓΟ/PROJECT

CITY MEDICAL CENTER

Υπογραφή Αρχιτέκτονα/Architect's Signature

ΕΤΕΚ Α / 69223

Υπογραφή/Signatures

Checked by G.L.

Στάδιο Μελέτης/Drawing Status
MARKETING PLANS


Σχέδιο/Drawing
2ND & 3RD FLOOR PLAN

Ημερομηνία Κατάθεσης/Submission Date
ΠΟΛΕΟΔΟΜΙΚΗ ΑΔΕΙΑ 13/03/2023


ΚΑΙΜΑΚΑ/ SCALE	1:100	ΑΡ. ΣΧΕΔΙΟΥ/ DRAWING No.
-------------------	-------	-----------------------------

ΗΜΕΡΟΜΗΝΙΑ/ DATE	8/5/2024	- M - 004
ΑΡ. ΜΕΛΕΤΗΣ/ PROJECT No.	2020-110	

© 2023 Leventis & Leventis Architects
© All Rights Reserved.
All materials embodied herein constitute an original work by the Architect.
The Architect owns all copyrights herein. The viewer may not reproduce, display or distribute this work or prepare derivative work based on this work without the express written consent of the copyright owner.

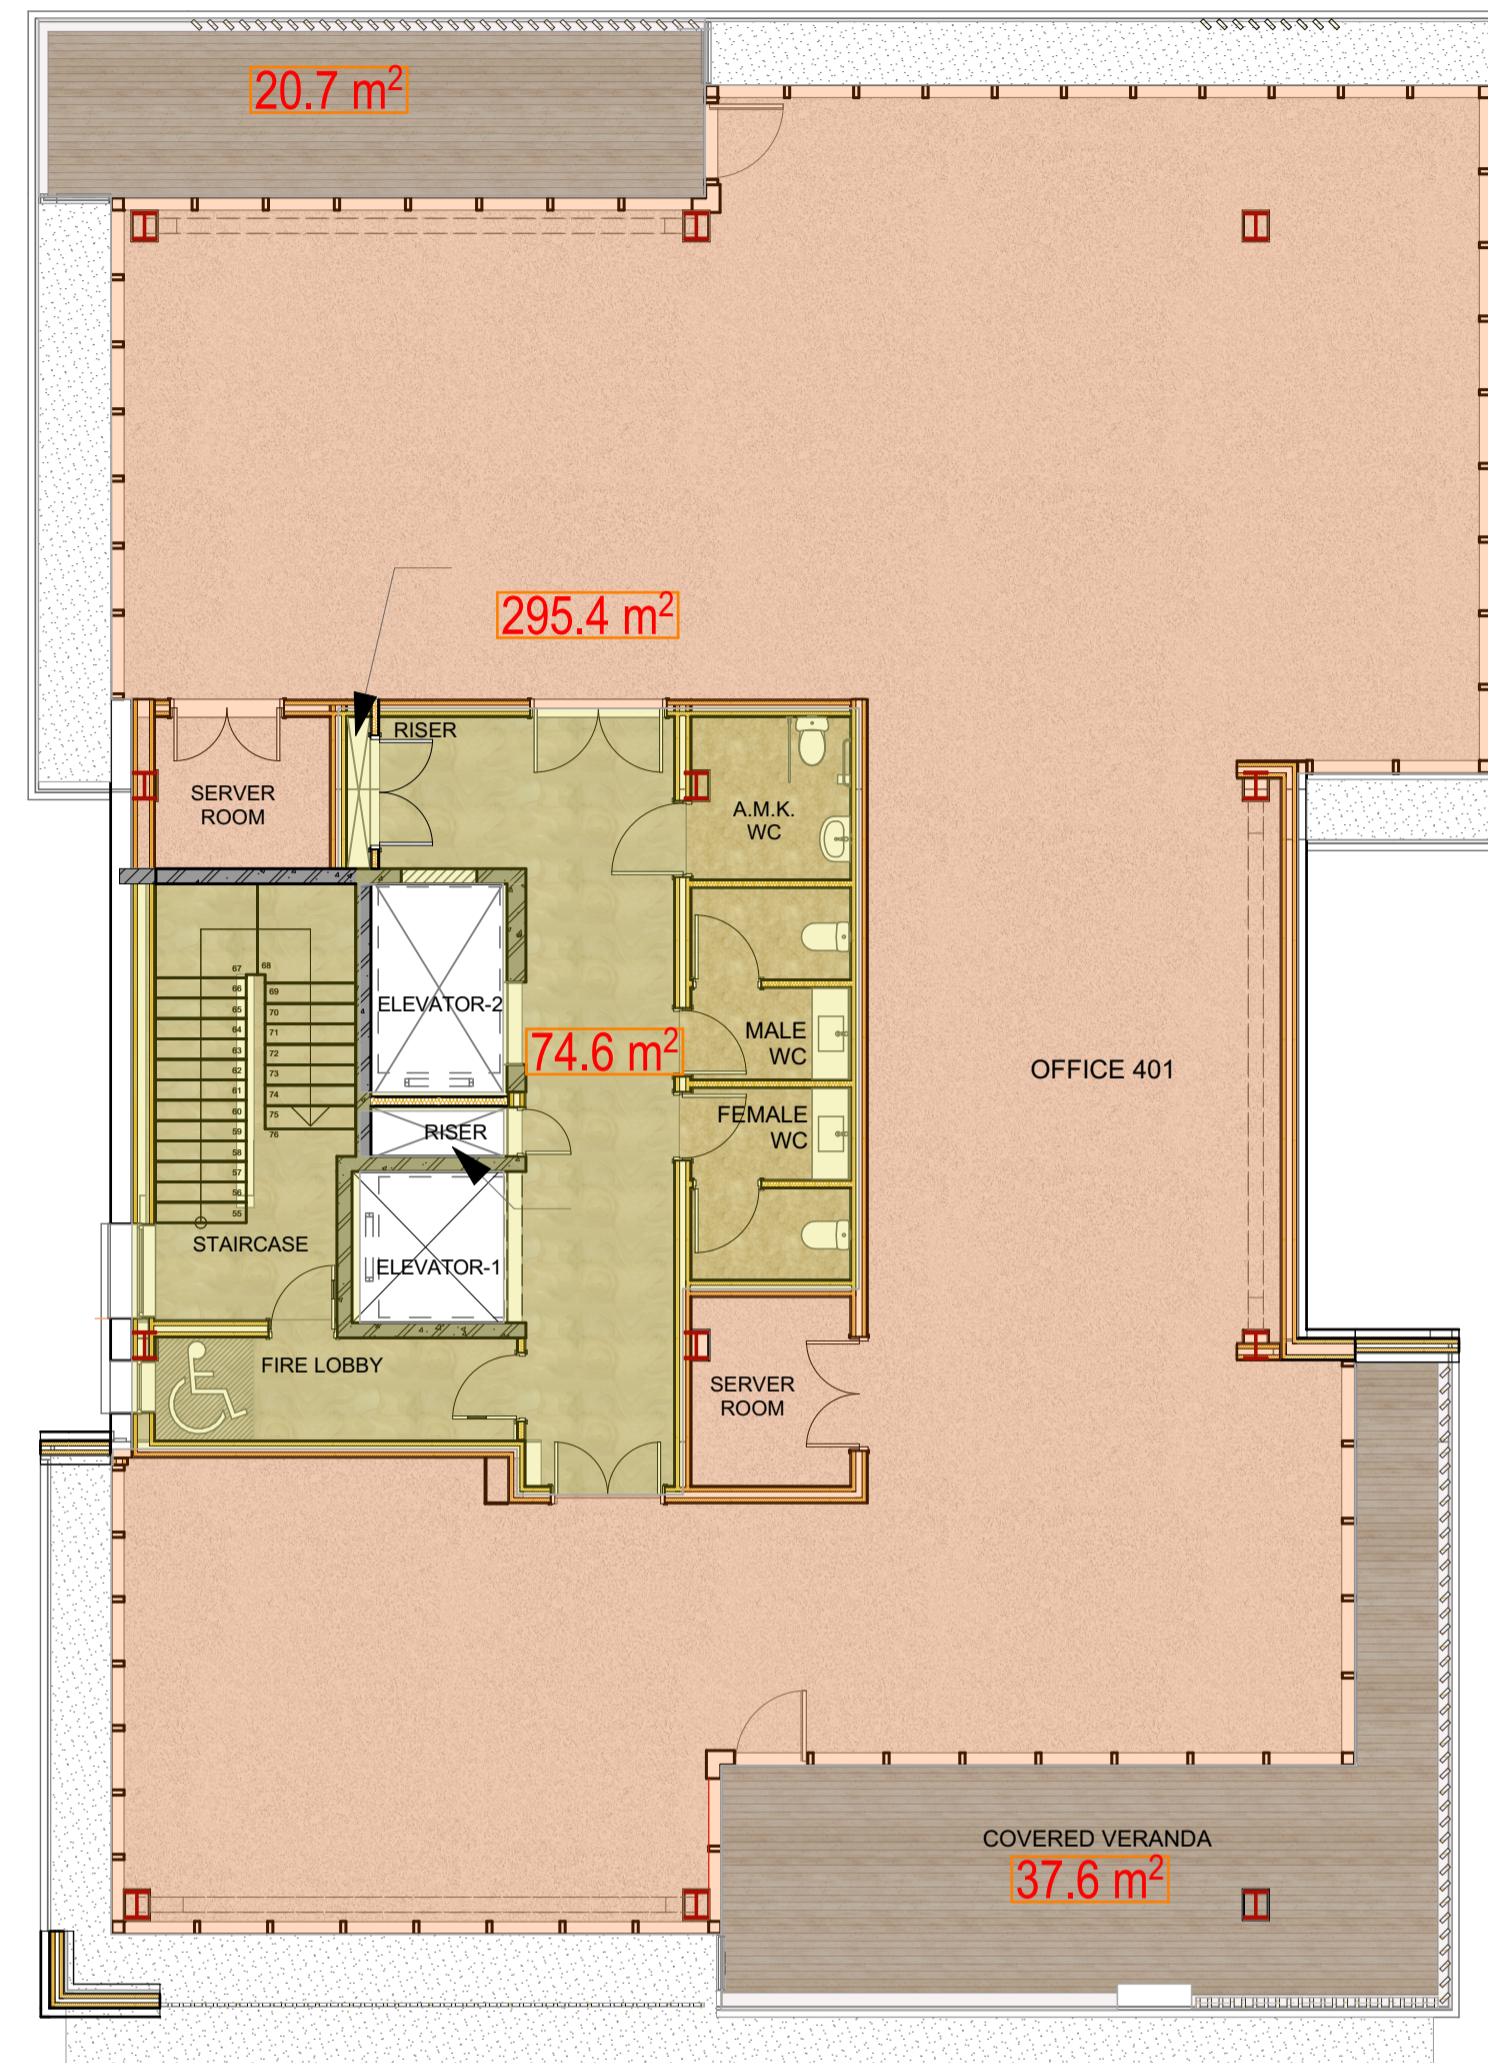

5. 4TH FLOOR PLAN
1:100

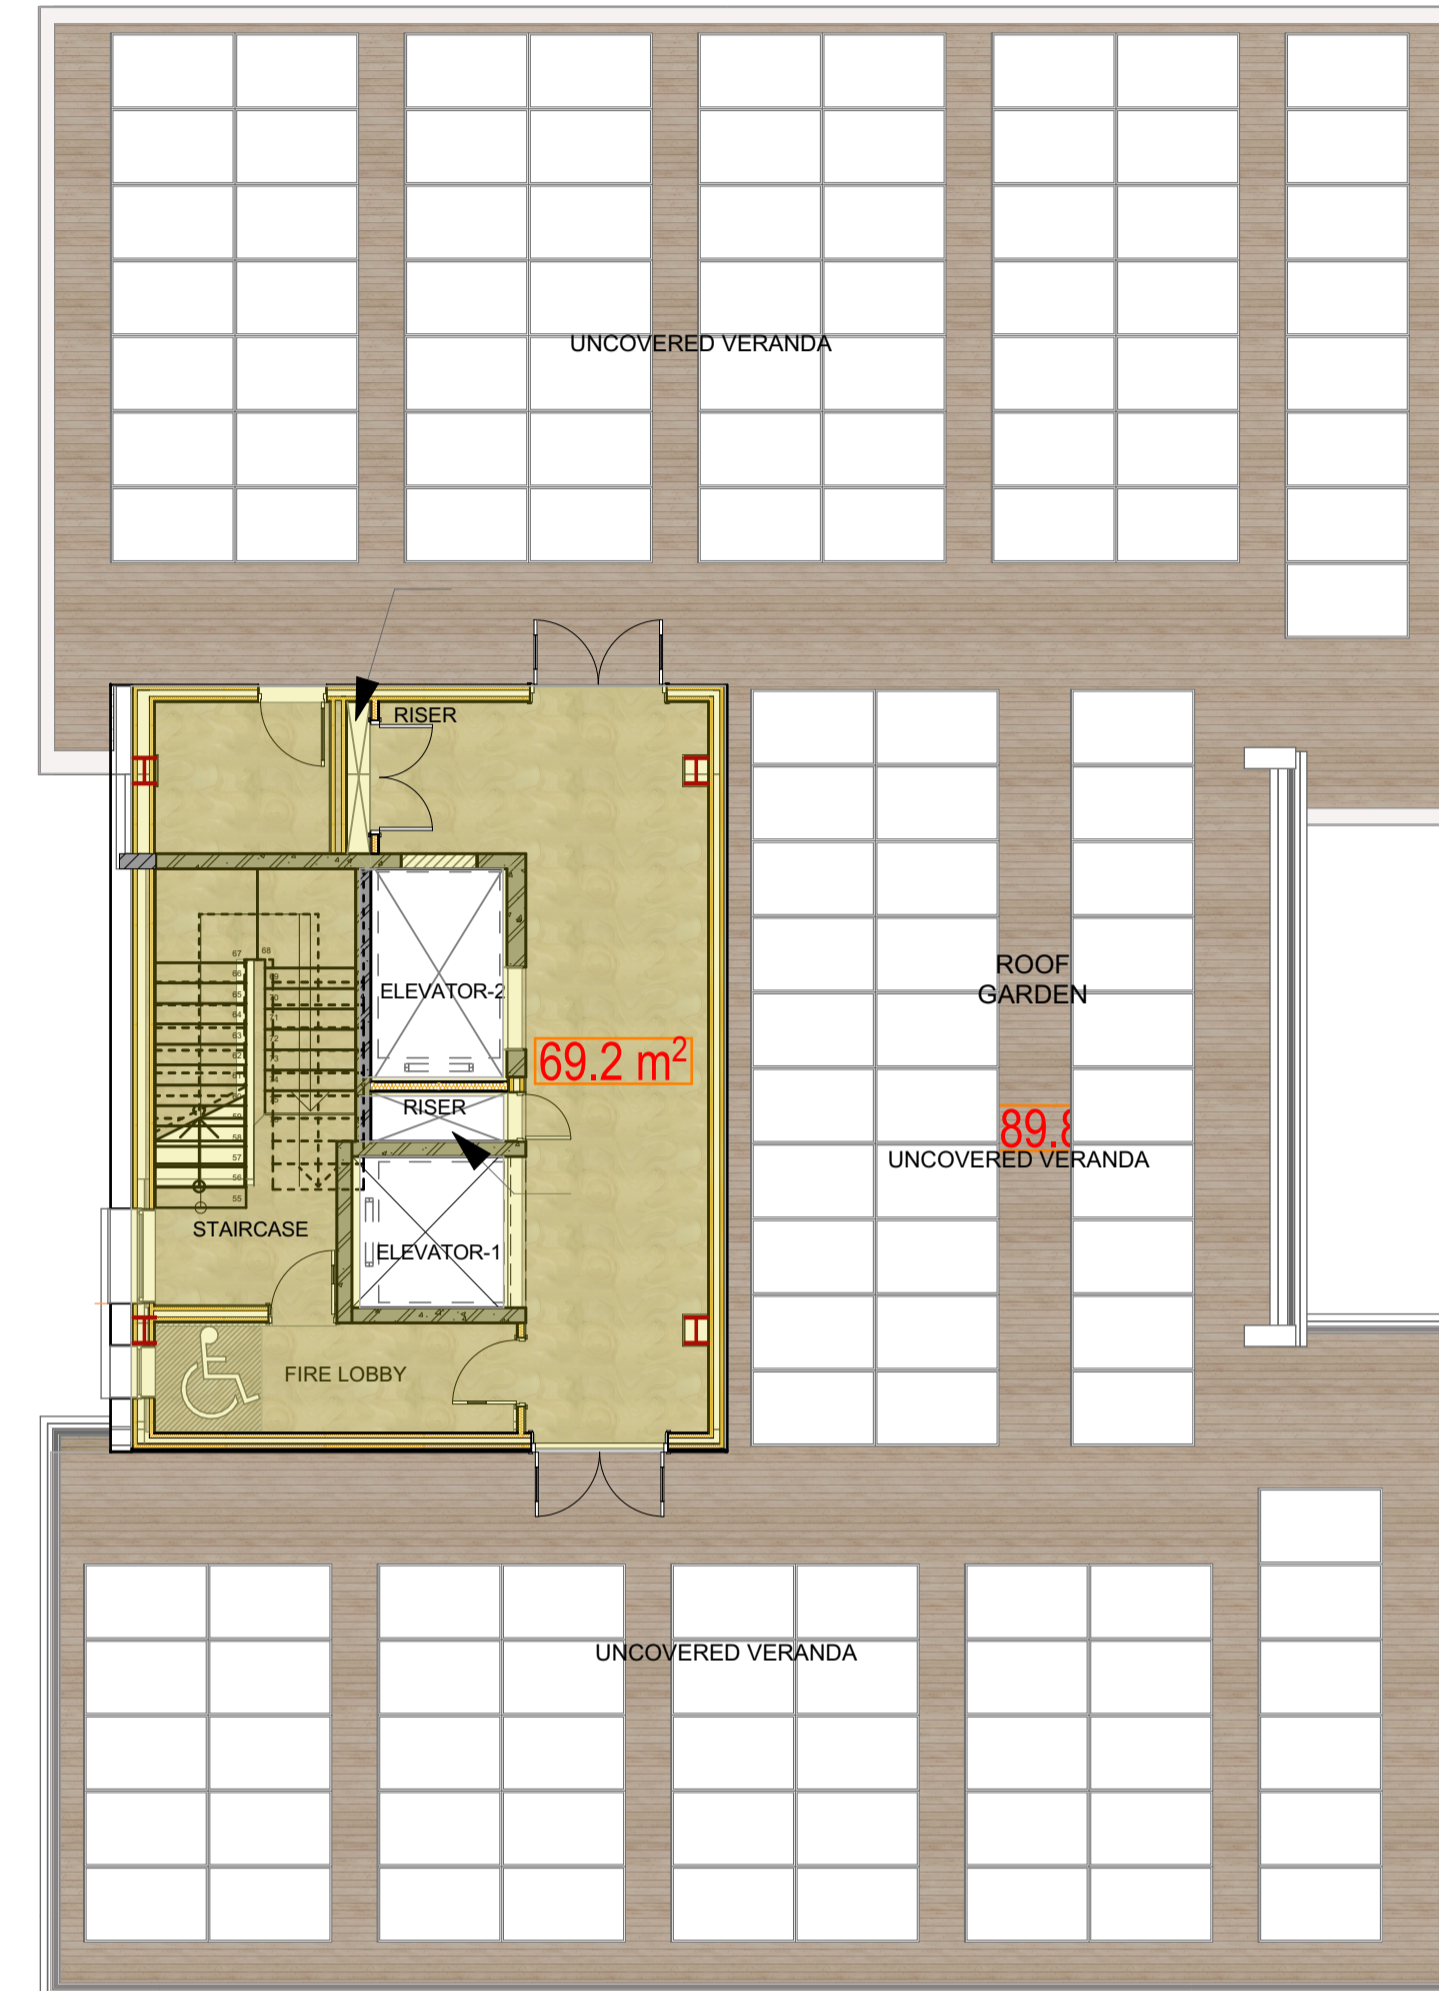

6. ROOF GARDEN PLAN
1:100

NOTES / ΠΑΡΑΤΗΡΗΣΕΙΣ

REVISIONS



Leventis & Leventis Architects
16, Emmanouil Roïdis street,
Limassol, Cyprus
P.C 3031
T: +357 25 362 846
F: +357 25 373 288
info@leventisgroup.com
http://www.leventisgroup.com

ΕΡΓΟ/PROJECT

CITY MEDICAL CENTER

Υπογραφή Αρχιτέκτονα/Architect's Signature

ΕΤΕΚ Α / 69223

Υπογραφή/Signatures

Checked by G.L.

Στάδιο Μακέτας/Drawing Status
MARKETING PLANS

Σχέδιο/Drawing
4TH FLOOR & ROOF GARDEN

Ημερομηνία Κατάθεσης/Submission Date
ΠΟΛΕΟΔΟΜΙΚΗ ΑΔΕΙΑ 13/03/2023

ΚΑΙΜΑΚΑ/ SCALE	1:100	ΑΡ. ΣΧΕΔΙΟΥ/ DRAWING No.
ΗΜΕΡΟΜΗΝΙΑ/ DATE	8/5/2024	- M -
ΑΡ. ΜΕΛΕΤΗΣ/ PROJECT No.	2020-110	005

© 2023 Leventis & Leventis Architects
© All Rights Reserved.
All materials embodied herein constitute an original work by the Architect.
The Architect owns all copyrights herein. The viewer may not reproduce, display or distribute this work or prepare derivative work based on this work without the express written consent of the copyright owner.